


KRUGER BENSEN ZIEMER
 ARCHITECTS, INC. AIA
 303 W. APPELLAGA STREET SANTA BARBARA, CA 93101
 TELEPHONE (805) 963-1726 FAX (805) 963-2951
 JOE S. WILCOX, AIA
 PROJECT ARCHITECT

All ideas, design arrangements and plans indicated or represented by this drawing are owned by and are the property of Kruger Bensen Ziemer. All architects and users are notified and developed for use in, and in connection with, the specified projects. None of such ideas, designs, arrangements or plans shall be used by or disclosed to any person, firm or corporation for any purpose whatsoever without the written permission of Kruger Bensen Ziemer.

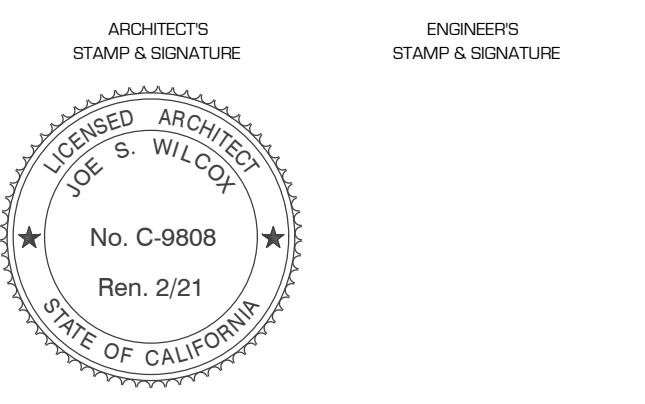


CONSULTANT INFORMATION
JMPE
 ELECTRICAL ENGINEERING
 LIGHTING DESIGN
 CA REGISTRATION NO. E13085
 17299
 627 OLIVE STREET
 SANTA BARBARA, CA 93105
 (805) 569-9216
 FAX (805) 569-2405
 email: maloney@jmpe.net



REVISION	DESCRIPTION	DATE	BY
DRAWN	CHECKED	DATE	
DATE	08/31/20		
JOB NO.	16047		
SHEET	EXISTING FIRE ALARM		
TITLE	SITE PLAN		

- PROVIDE 2" C. FROM:
- MDF TO ROOM 11 IDF
 - MDF TO FOOD SERVICES IDF
 - FOOD SERVICES IDF TO WAREHOUSE IDF
 - MDF TO PUPIL SVCS IDF

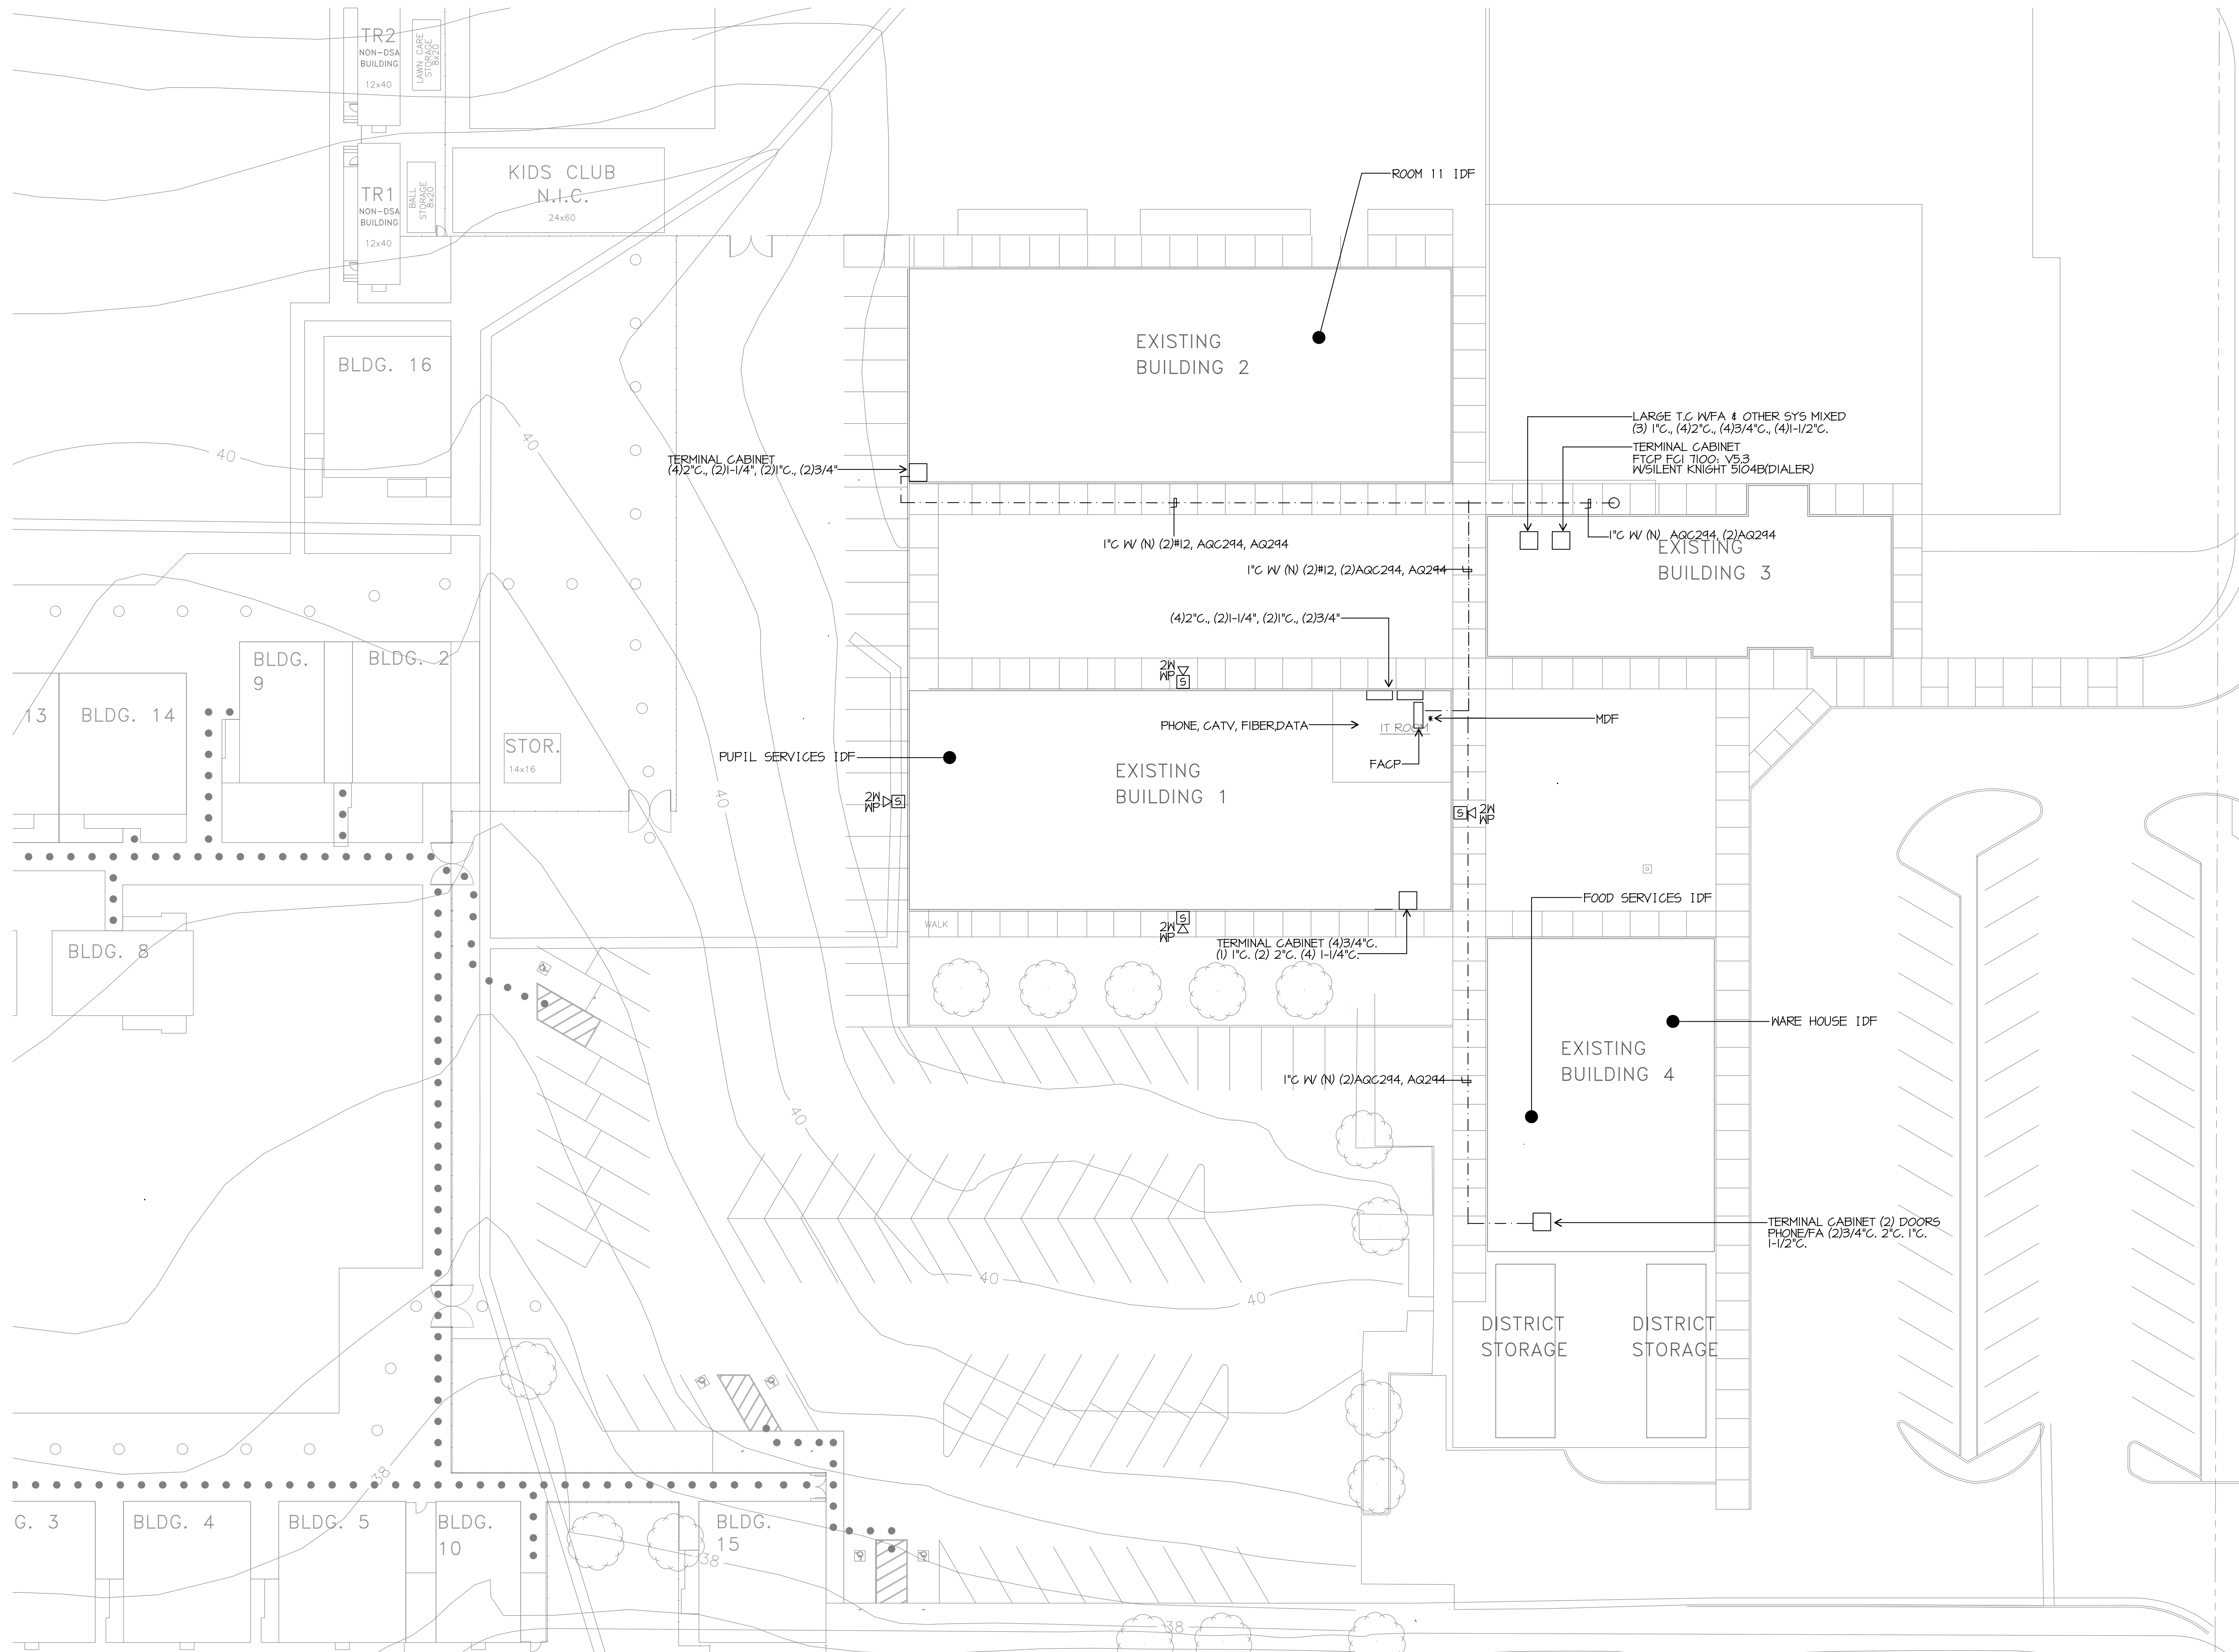

EXISTING FIRE ALARM SITE PLAN

SCALE: 1"=20'-0"

